


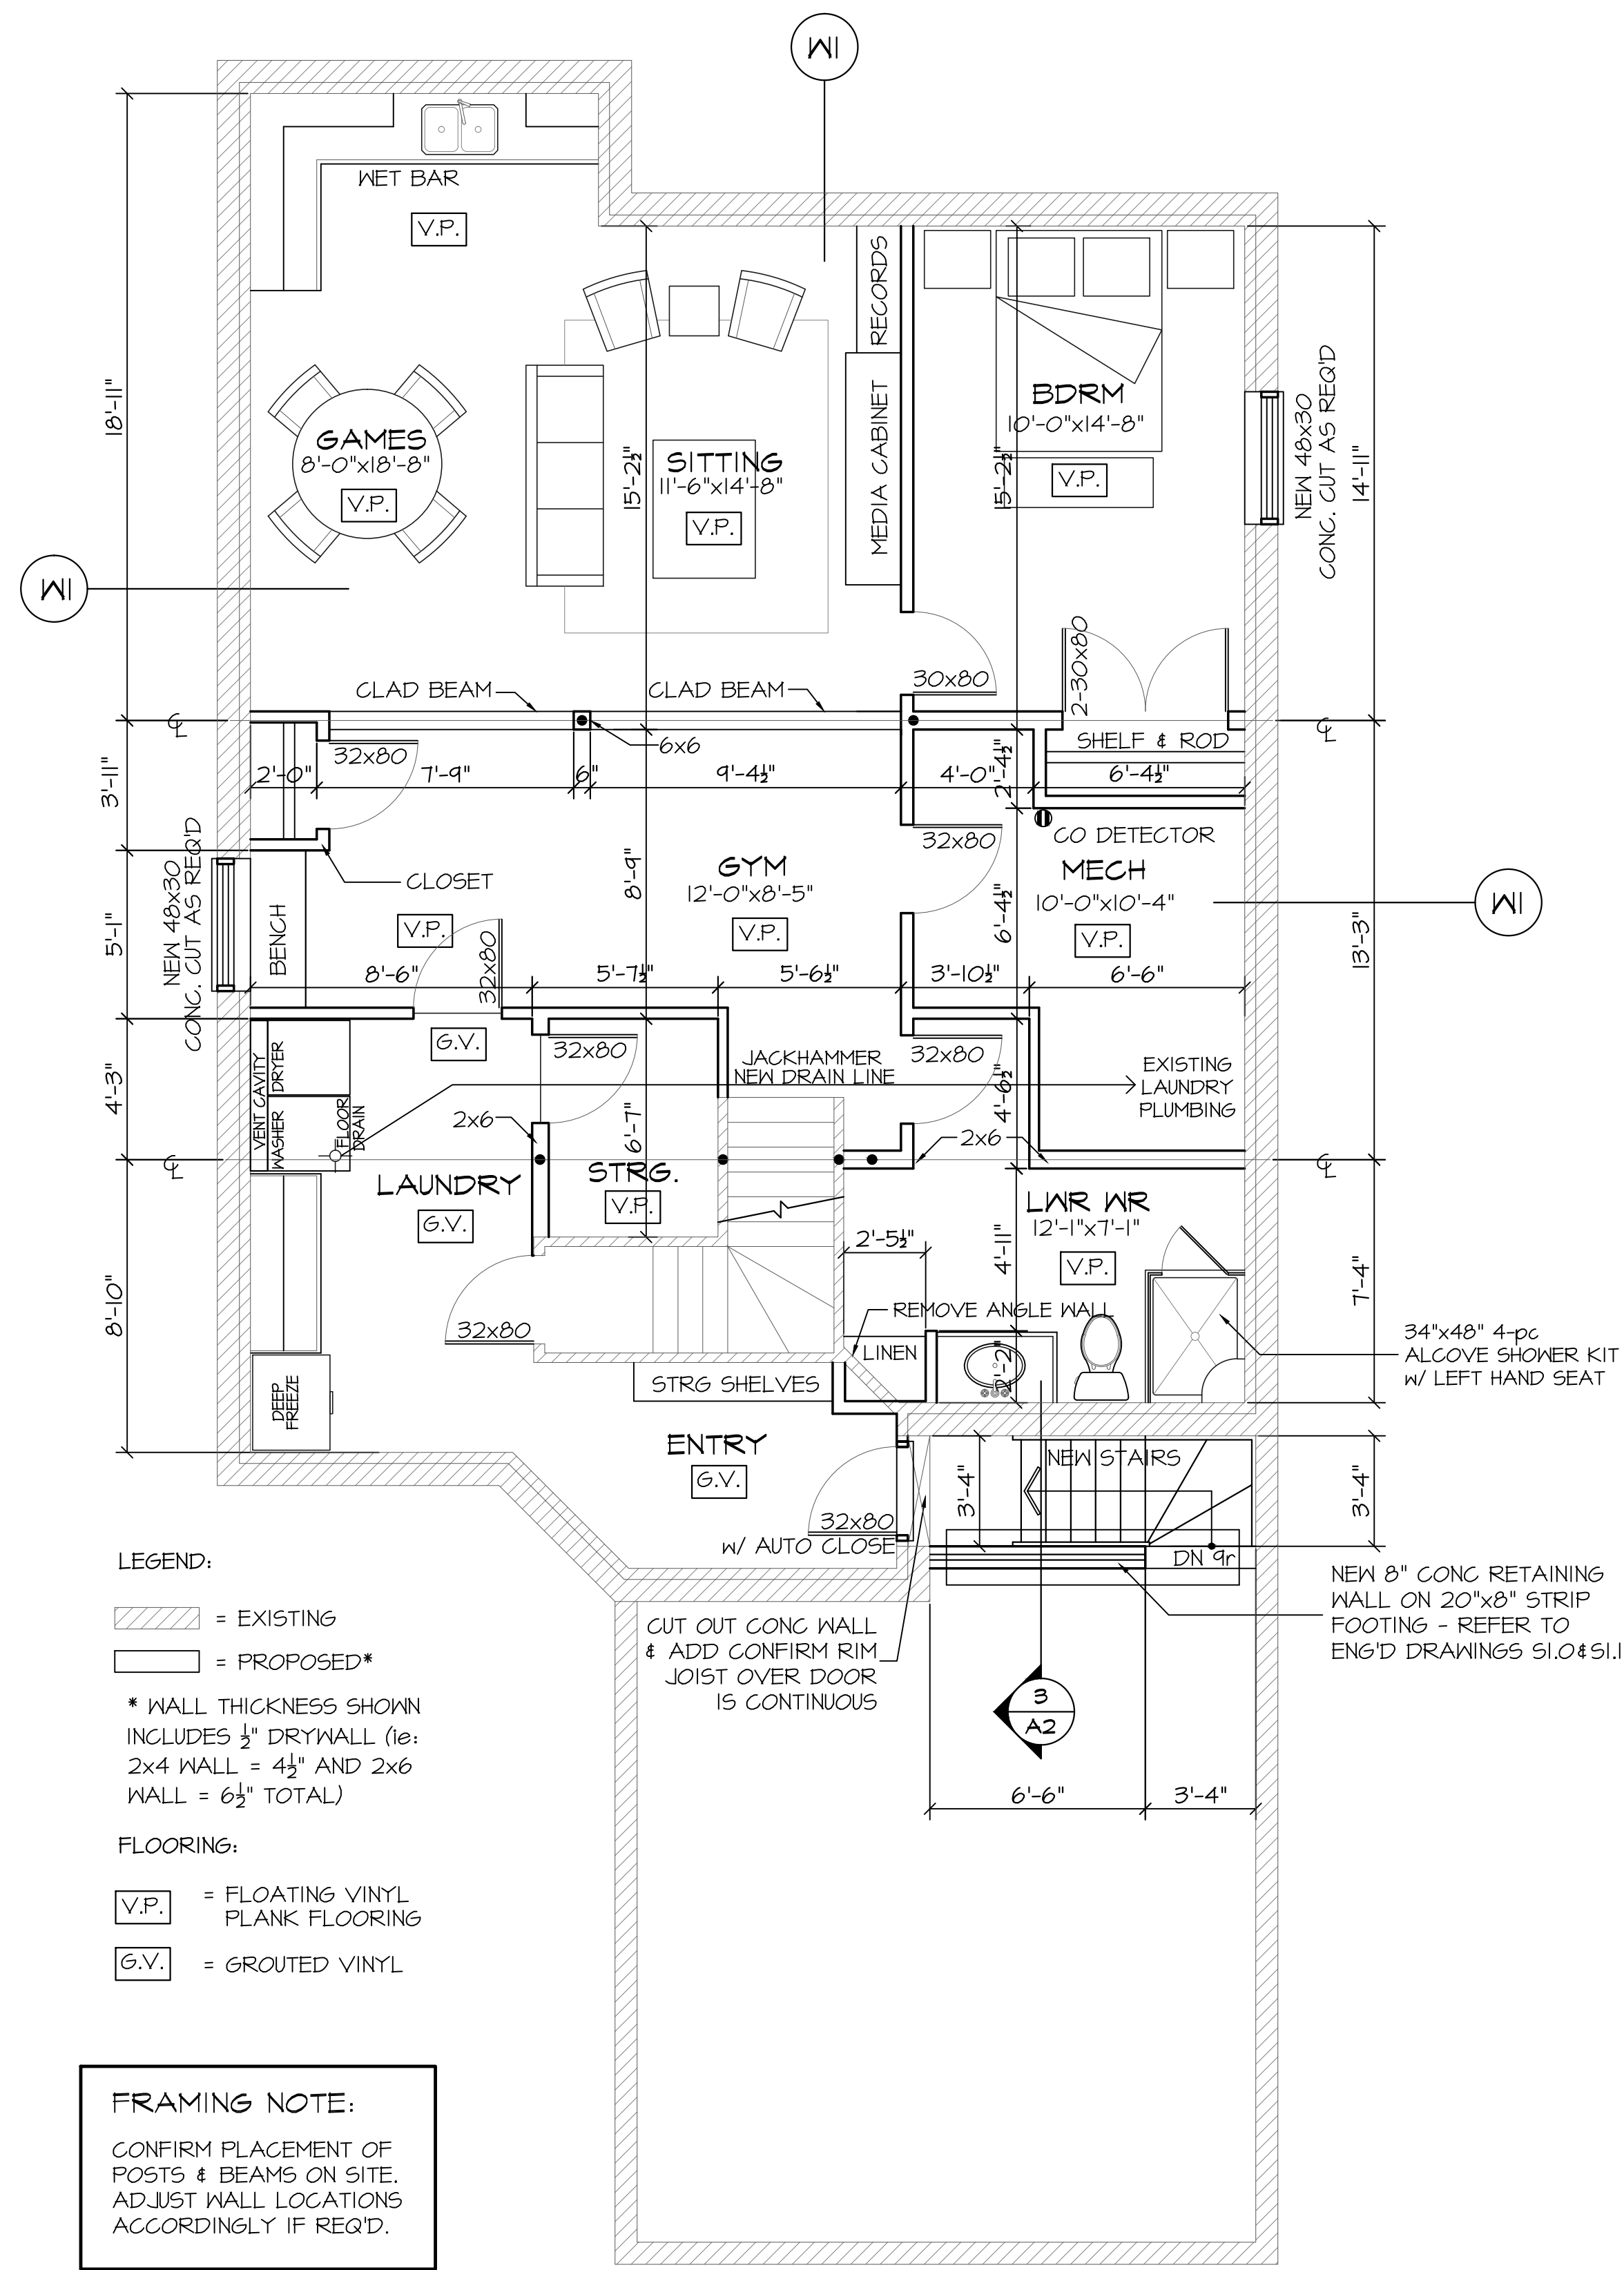



1 BASEMENT DEVELOPMENT PLAN
SCALE: 1/4" = 1'-0"

TOTAL AREA FOR DEVELOPMENT: 1087 SQ. FT.
UNDEVELOPED MECH & STORAGE: 133 SQ. FT.
NEW STAIRCASE FROM GARAGE: 22 SQ. FT.

ELECTRICAL LEGEND	
	DUPLEX RECEPTACLE
	DUPLEX RECEPTACLE 41" FROM FLOOR TO TOP OF BOX
	GROUND FAULT INTERRUPTOR
	220 V OUTLET
	CEILING LIGHT
	WALL MOUNT LIGHT
	POT LIGHT
	WALL SWITCH
	3 WAY WALL SWITCH
	4 WAY WALL SWITCH
	CABLE TELEVISION OUTLET
	SMOKE DETECTOR
	CEILING EXHAUST FAN
	CARBON MONOXIDE DETECTOR


2 BASEMENT ELECTRICAL PLAN
SCALE: 1/4" = 1'-0"

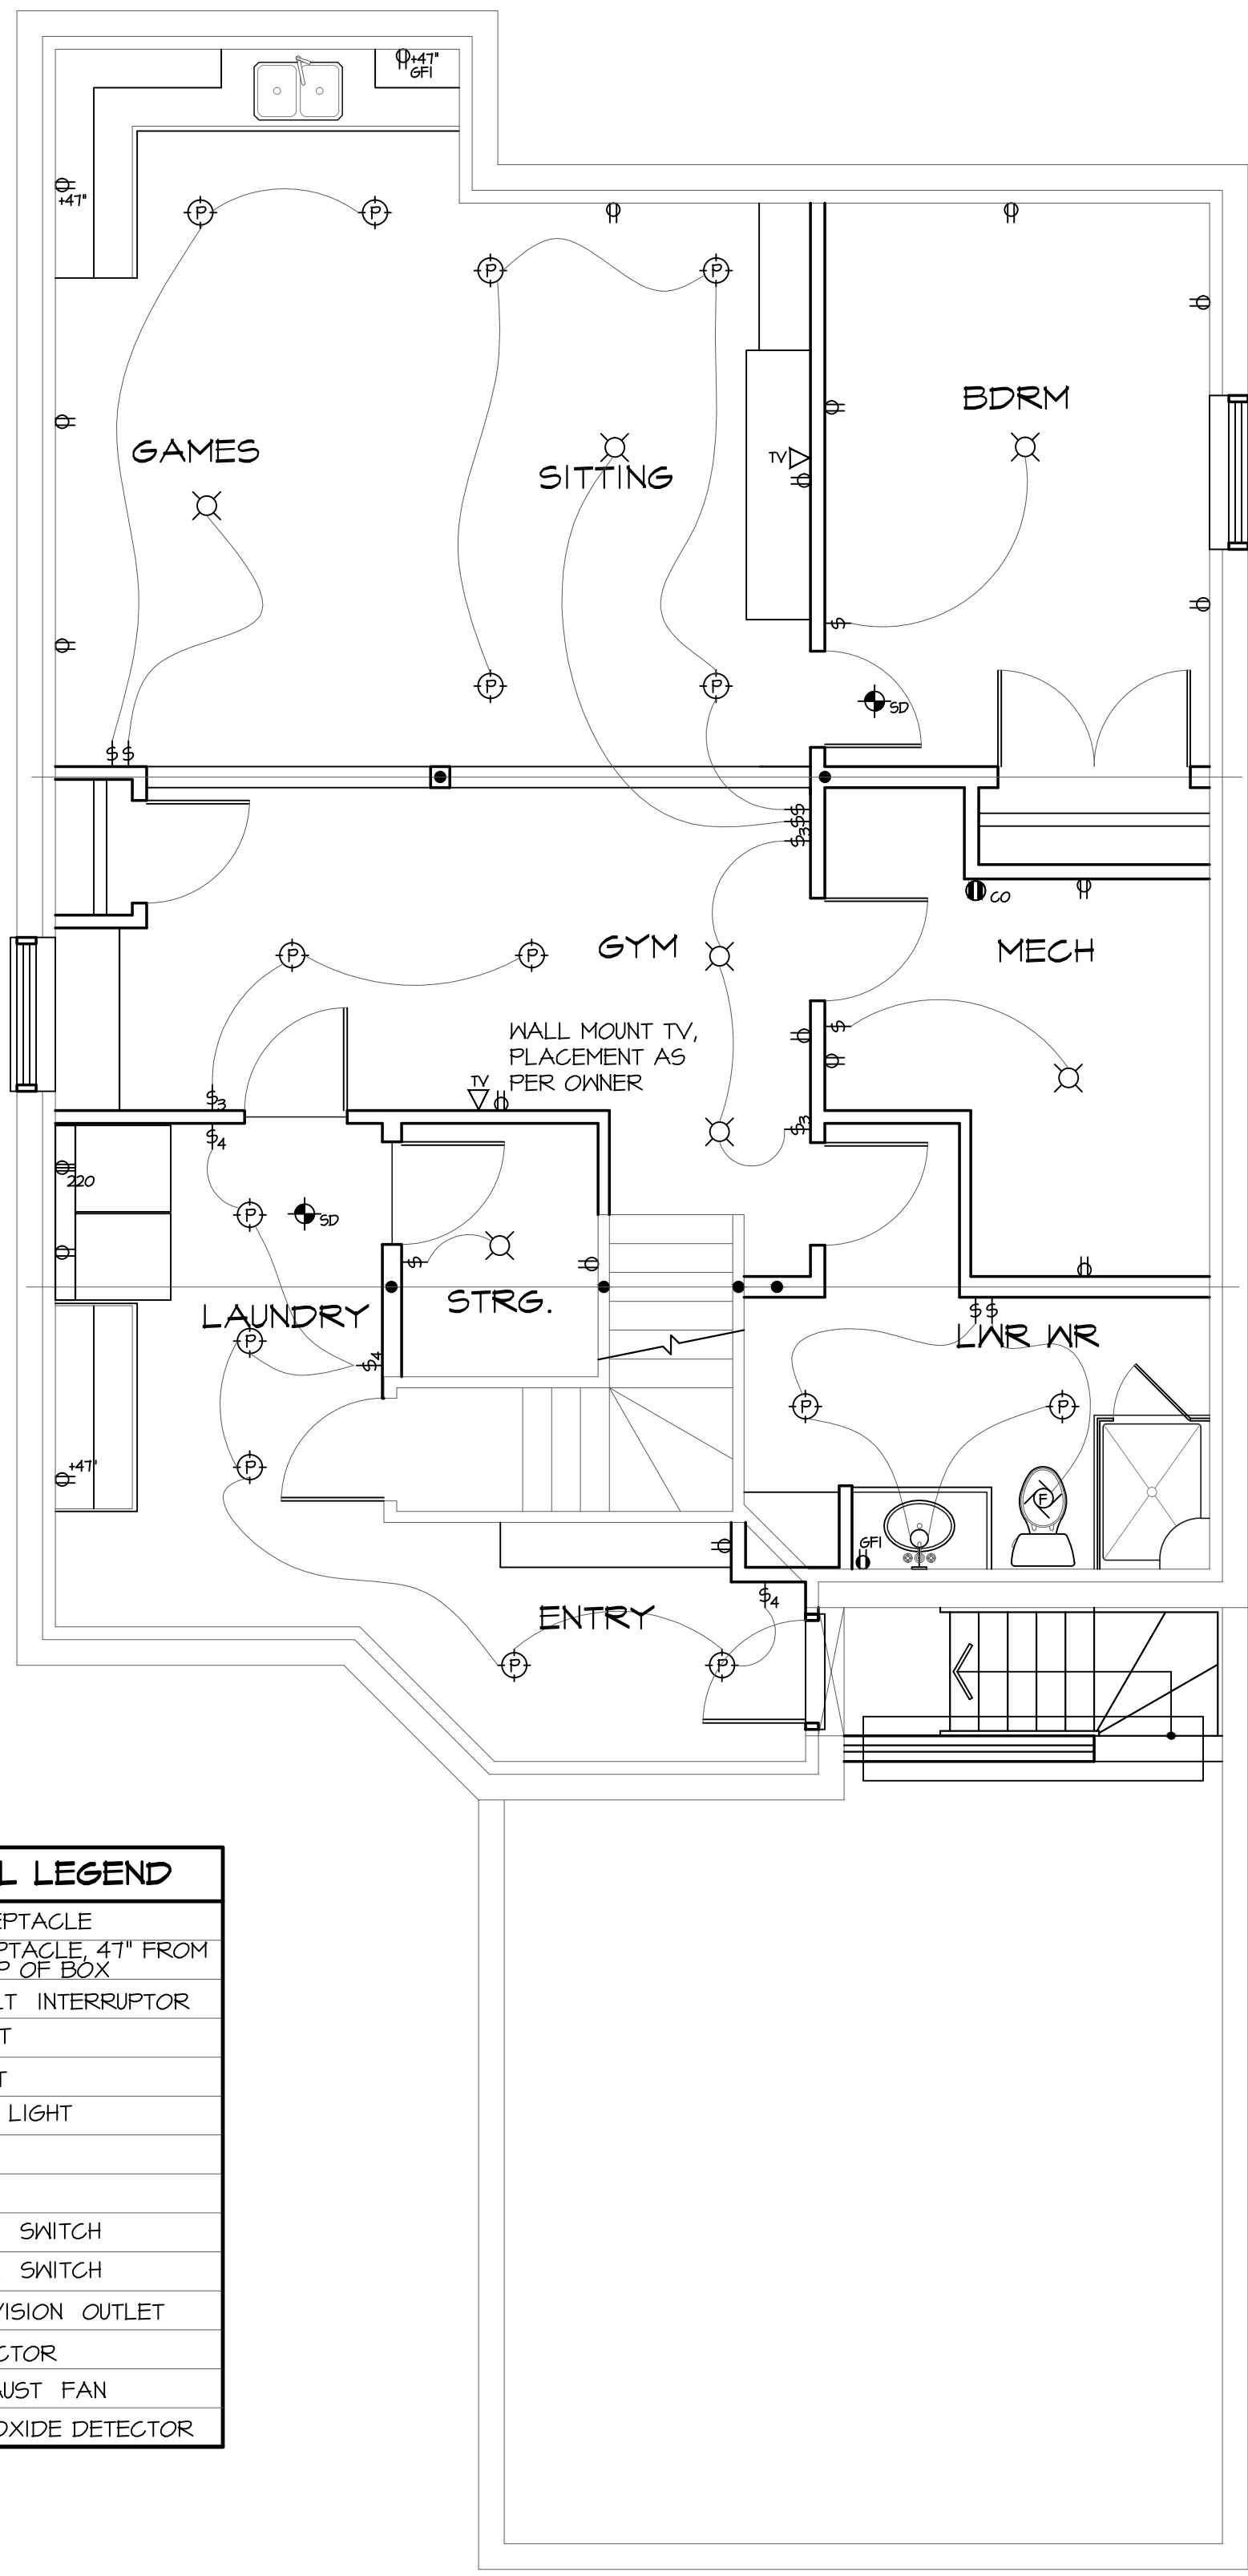

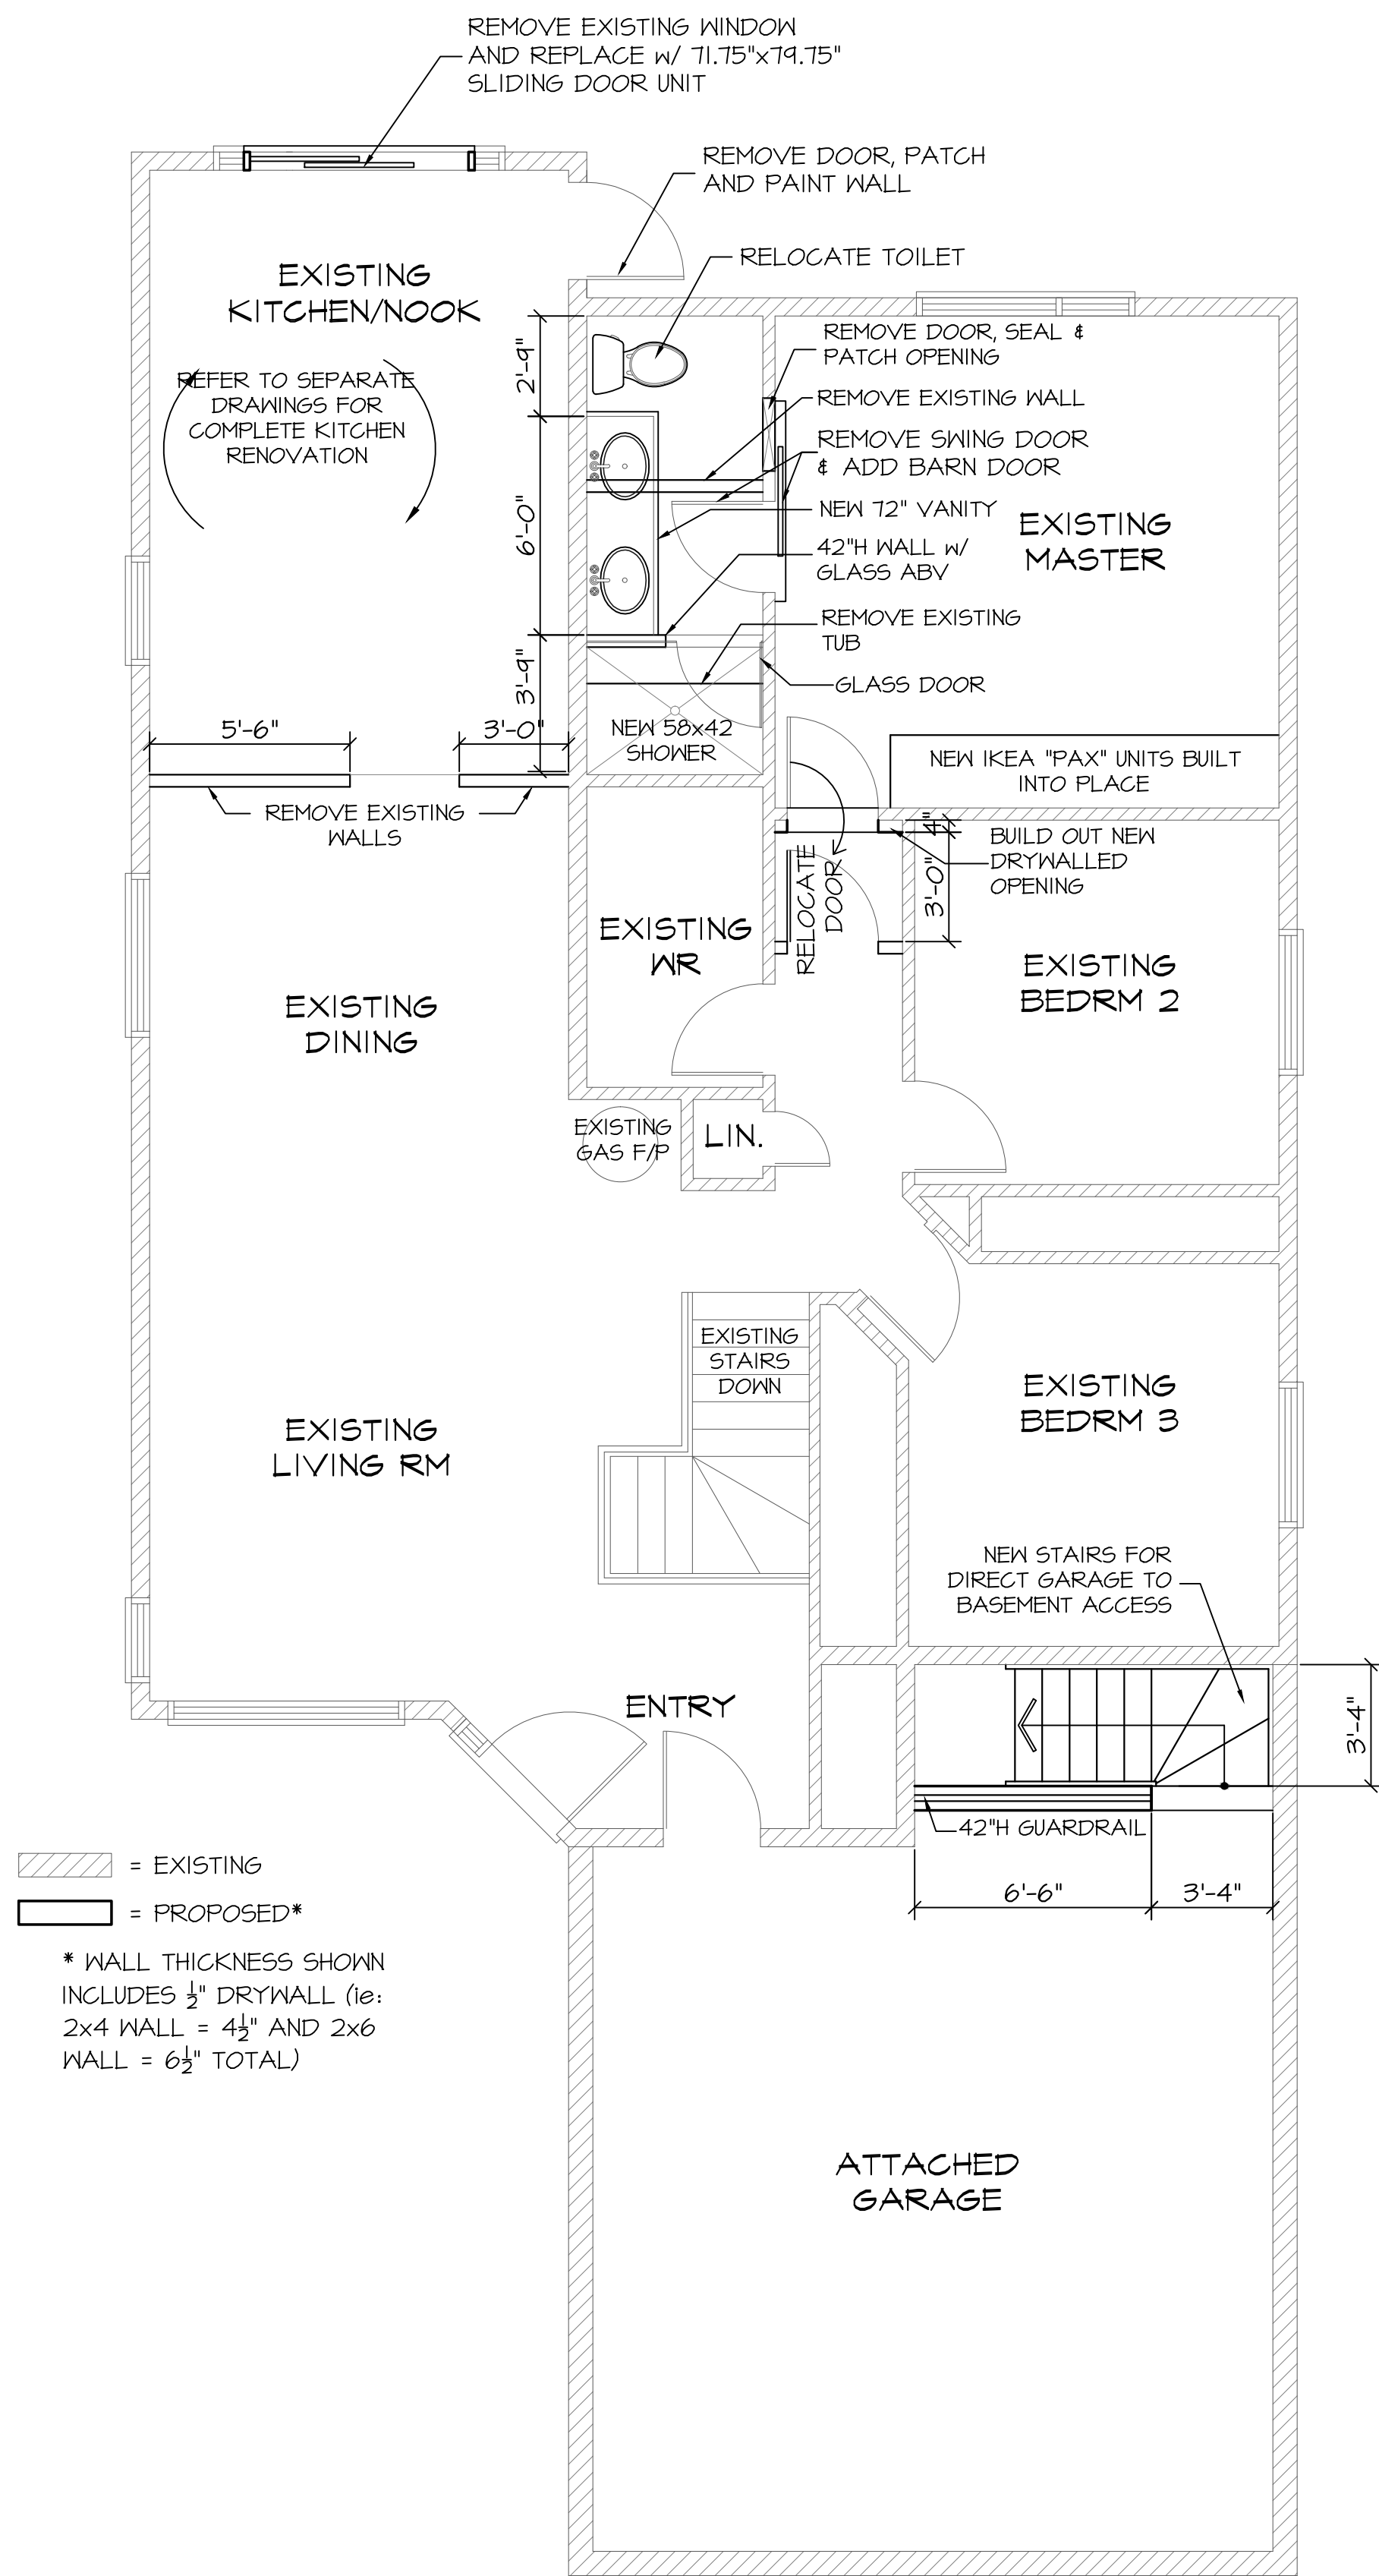


1
A2 MAIN FLOOR RENOVATION PLAN
SCALE: 1/4" = 1'-0"

TOTAL MAIN FLOOR AREA: 1322 SQ. FT.
RENOVATED SPACES: 260 SQ. FT. (+/-)

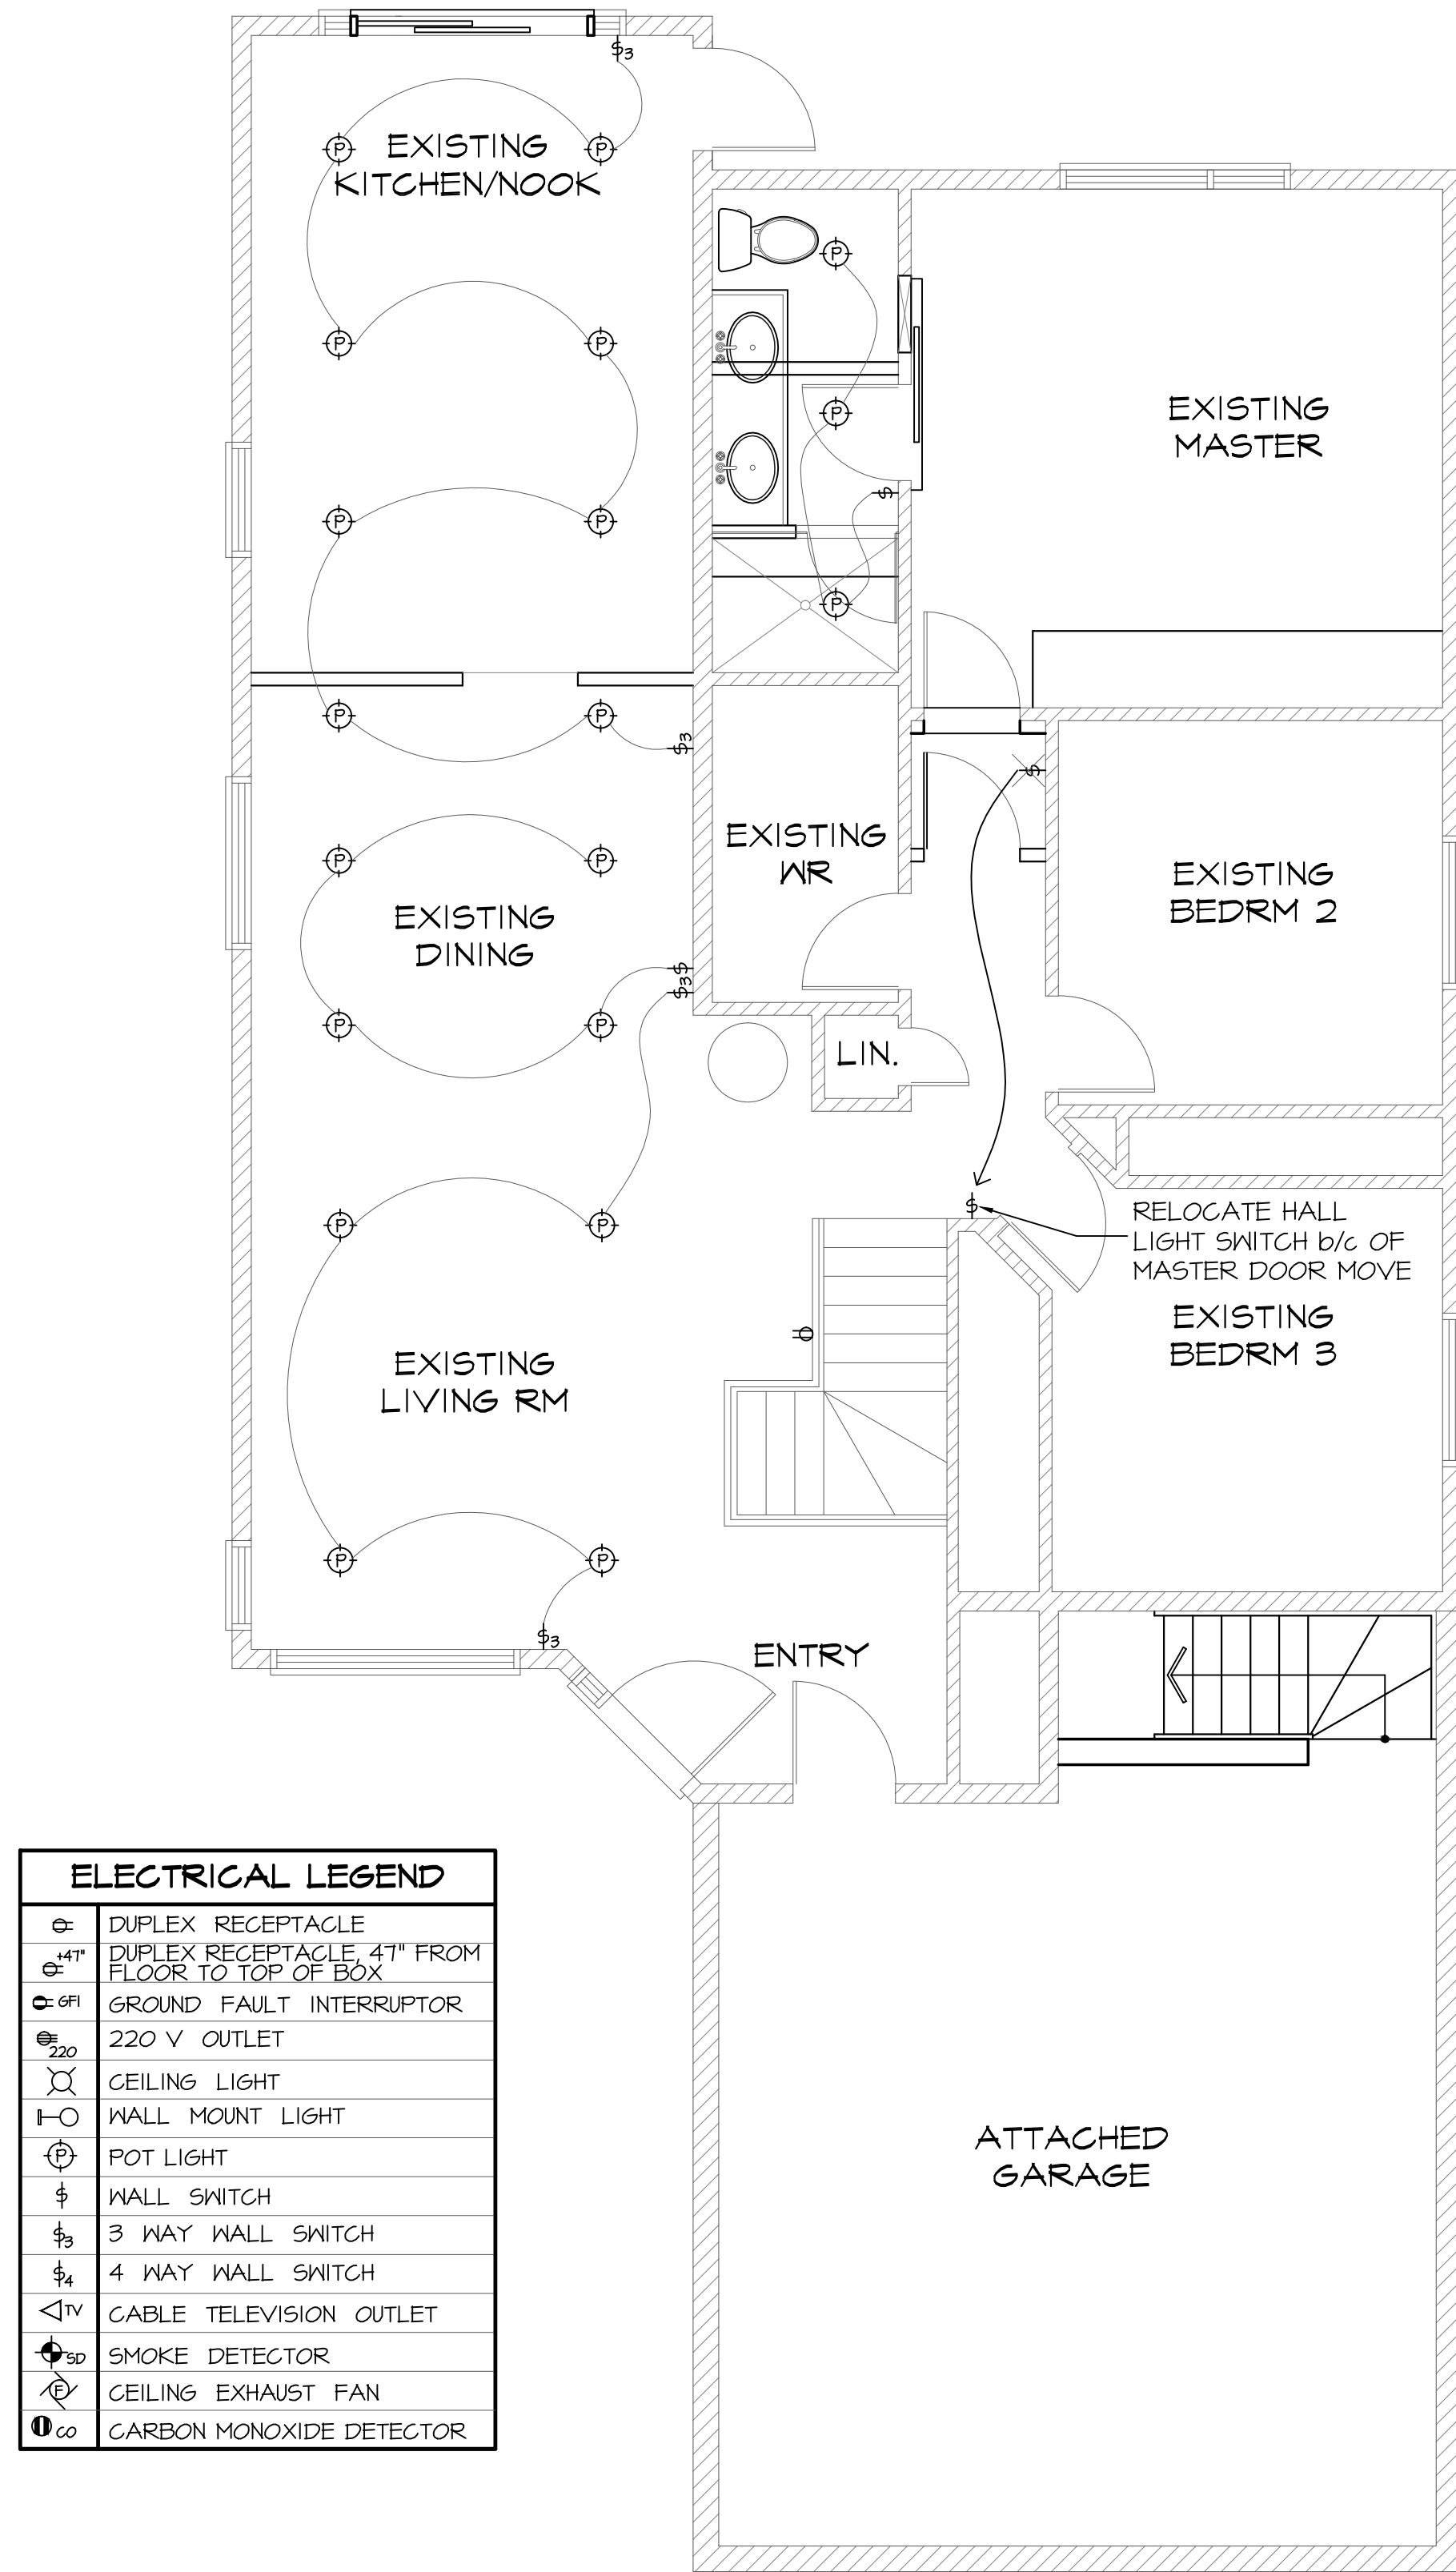

ELECTRICAL LEGEND	
	DUPLEX RECEPTACLE
	DUPLEX RECEPTACLE, 41" FROM FLOOR TO TOP OF BOX
	GROUND FAULT INTERRUPTOR
	220 V. OUTLET
	CEILING LIGHT
	WALL MOUNT LIGHT
	POT LIGHT
	WALL SWITCH
	3 WAY WALL SWITCH
	4 WAY WALL SWITCH
	CABLE TELEVISION OUTLET
	SMOKE DETECTOR
	CEILING EXHAUST FAN
	CARBON MONOXIDE DETECTOR

2
A1 MAIN FLOOR ELECTRICAL PLAN
SCALE: 1/4" = 1'-0"

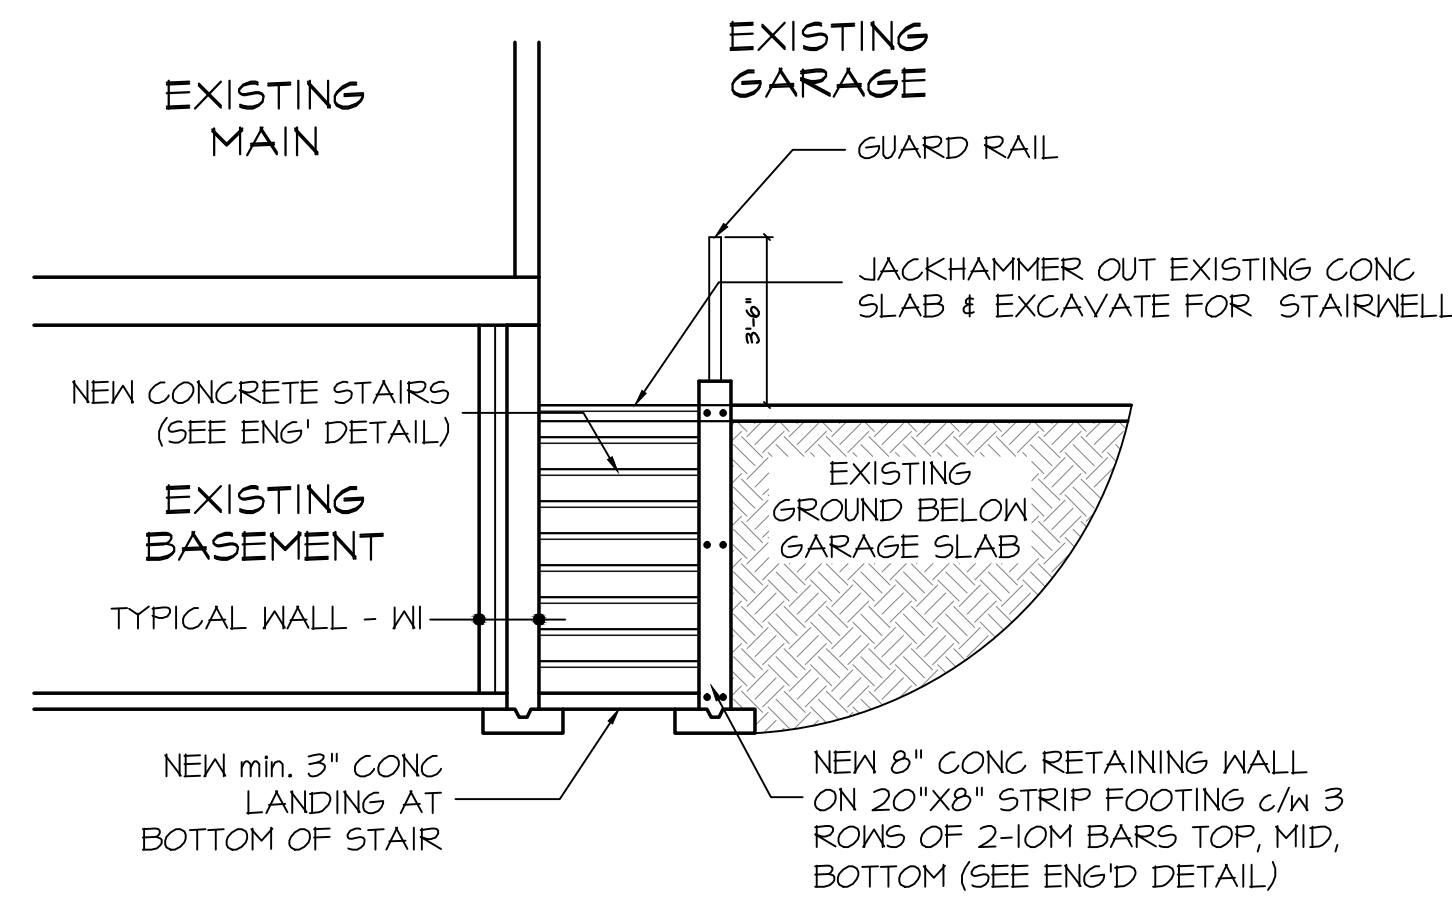

3
A2 NEW STAIRWELL SECTION
SCALE: 1/4" = 1'-0"

* REFER TO ENGINEER DETAILS ON SHEETS S1.0 & S1.1 *